
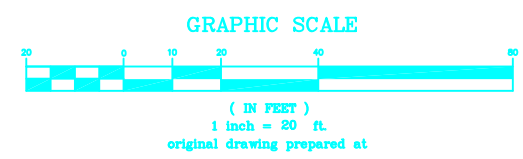
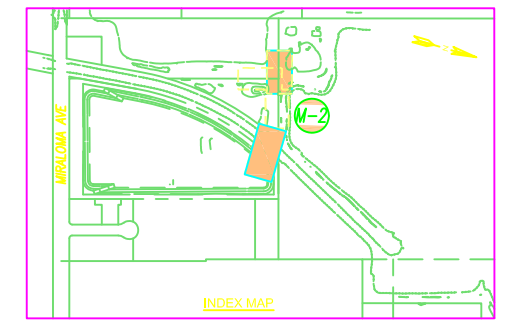
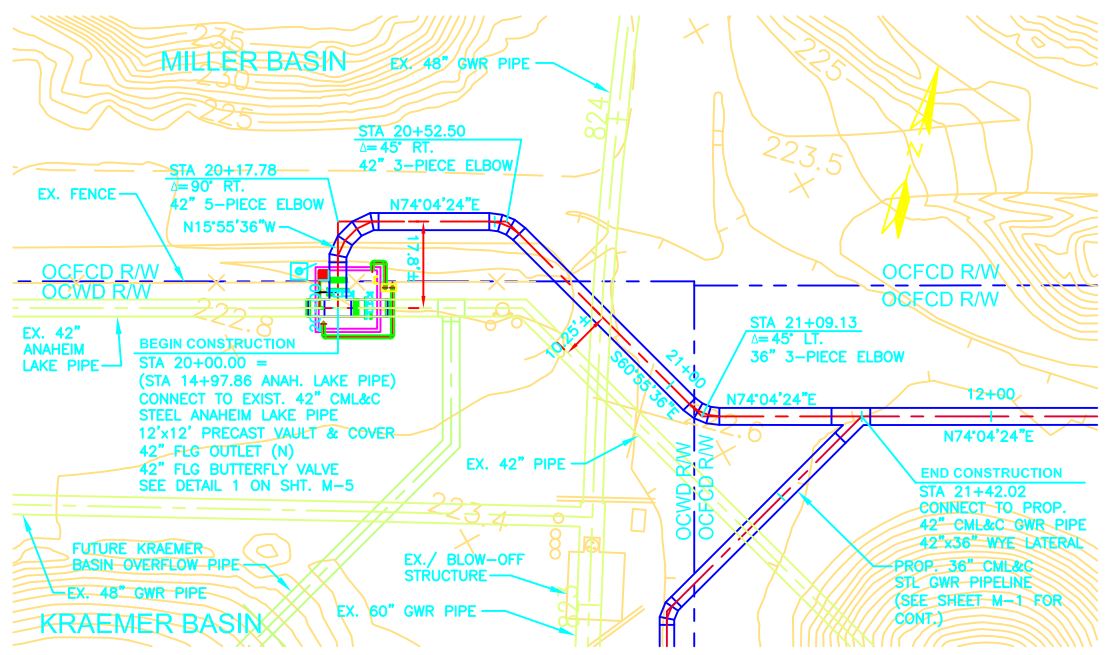
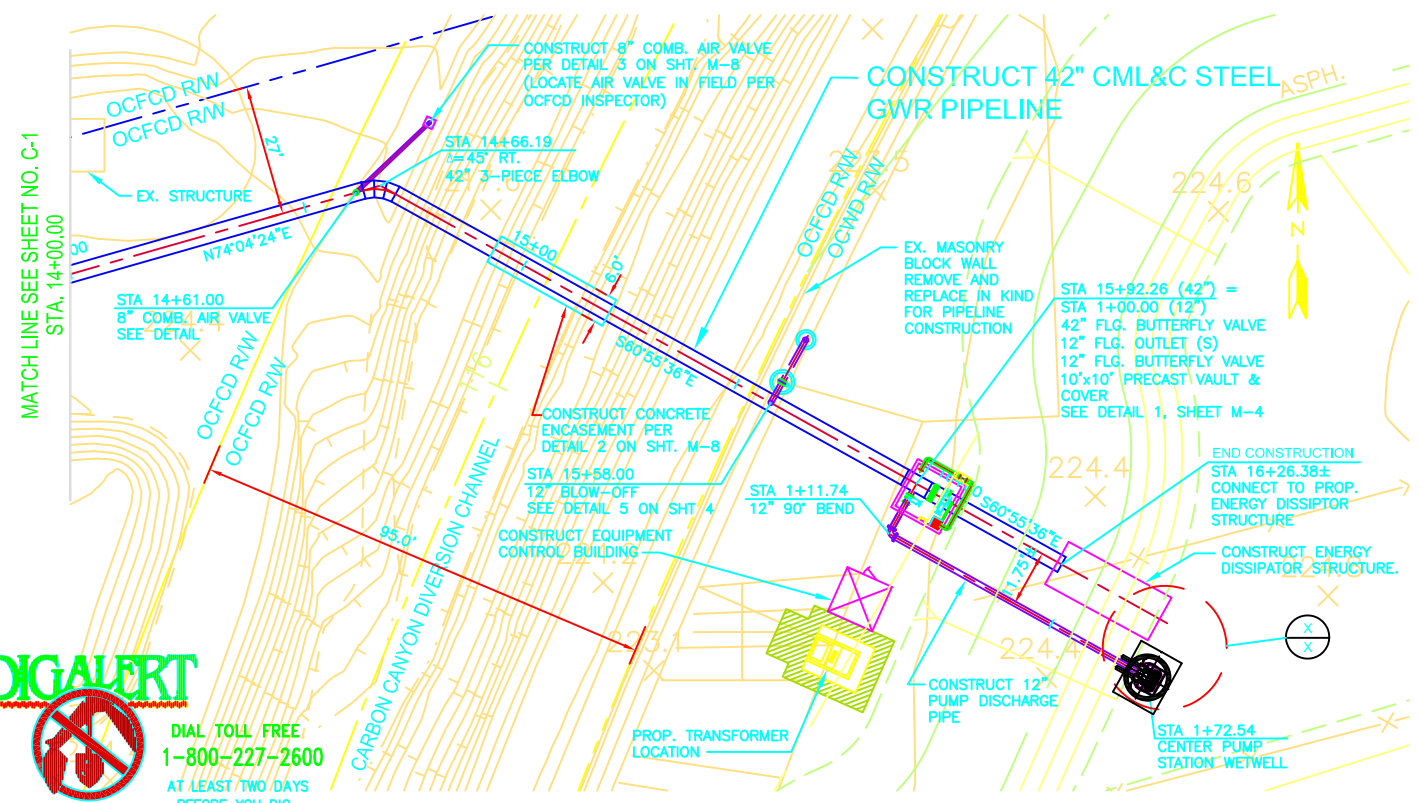


HORIZ. 1"=20'
VERT. 1"=4'

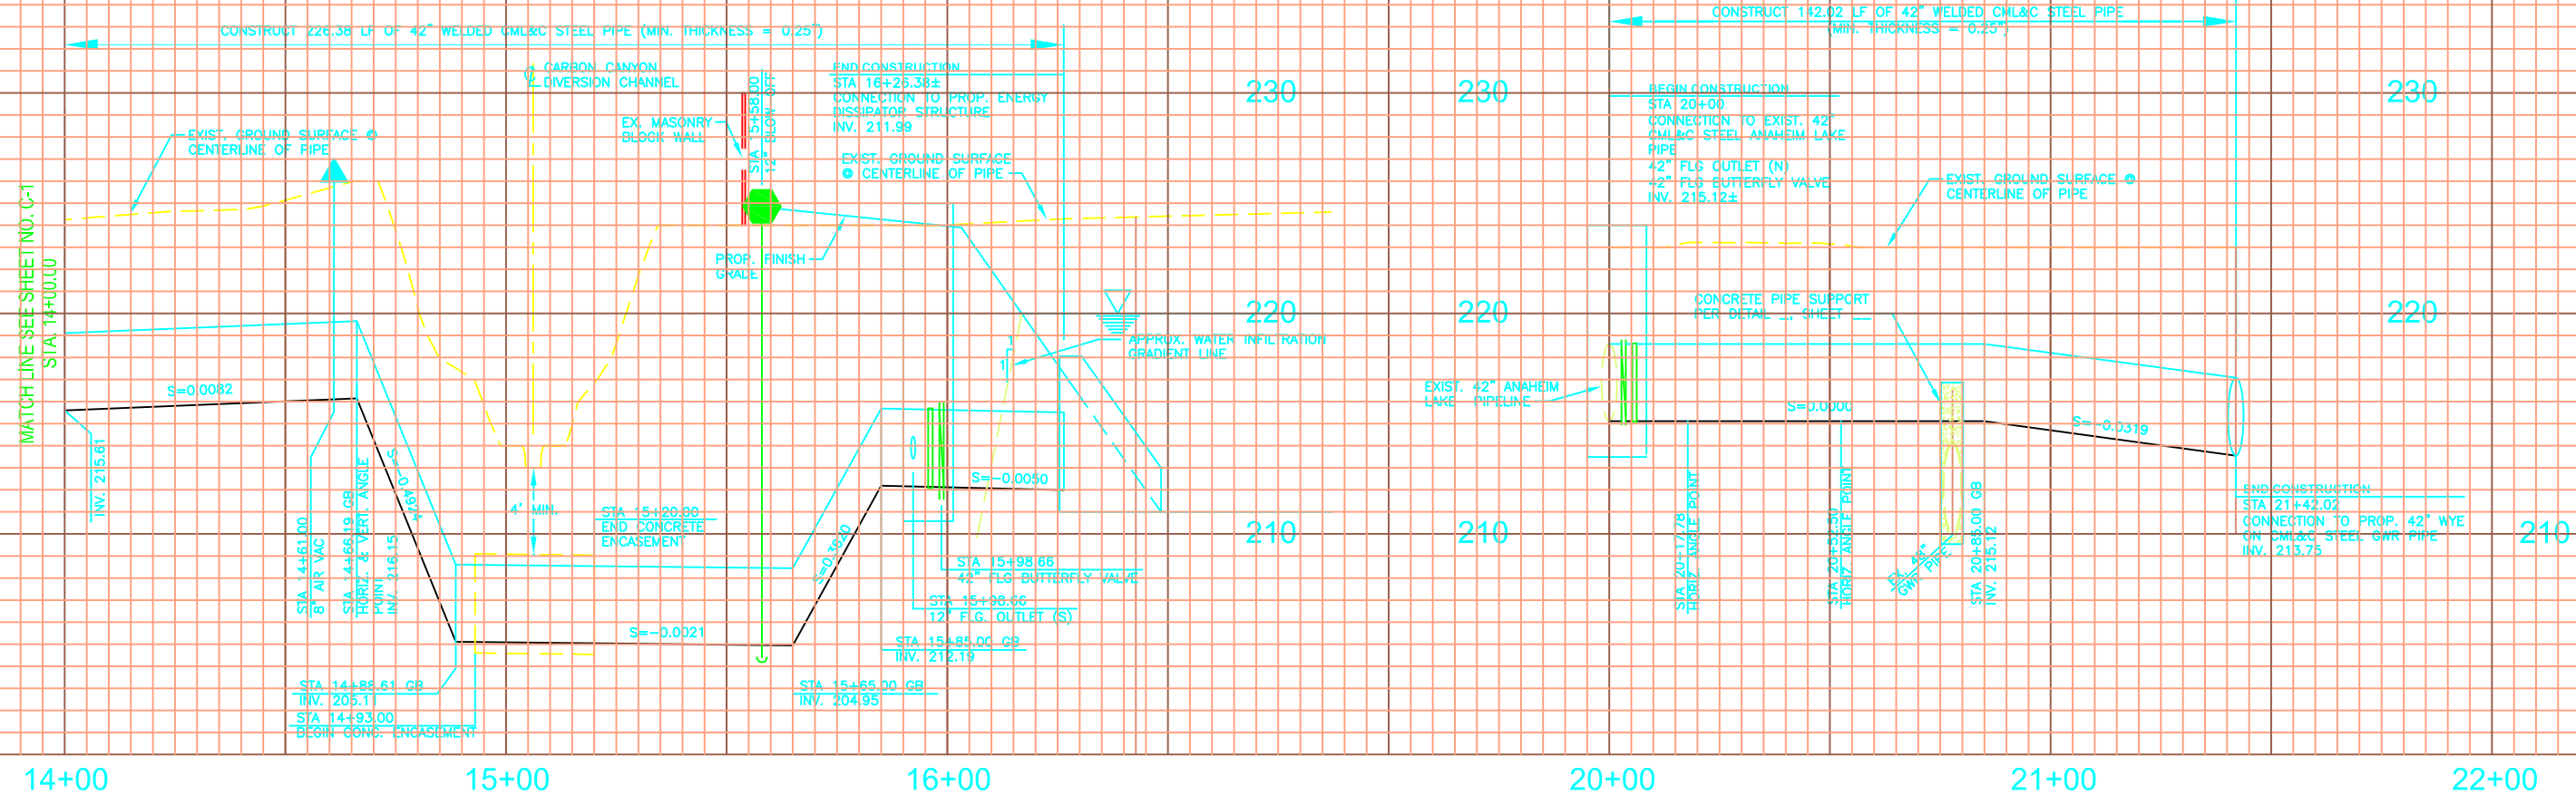

42" ANAHEIM LAKE SUPPLY PIPELINE

DIGALERT
DIAL TOLL FREE
1-800-227-2600
AT LEAST TWO DAYS
BEFORE YOU DIG
UNDERGROUND SERVICE ALERT OF SOUTHERN CALIFORNIA

REV.	DATE	DESCRIPTION	APP.

DATE	DATE
05/4/2011	
DRAWN	JOB NO.
RS	2040481500
CHECKED	DRAWING NO.
KB	

PREPARED BY:
STANTEC CONSULTING INC.
19 TECHNOLOGY DRIVE
IRVINE, CA 92618
949.923.6000
stantec.com

KEVIN B. BRANDT RCE 54873 EXP 06/30/12 DATE

ORANGE COUNTY WATER DISTRICT
18700 WARD STREET
FOUNTAIN VALLEY, CALIFORNIA 92708
TELEPHONE: 714-378-3200



MIRALOMA RECHARGE BASIN PROJECT
**GWR & ANAHEIM LAKE SUPPLY PIPELINES
PLAN AND PROFILE**
FROM STATION 10+00.00 TO STA 16+26.38±
FROM STATION 20+00.00 TO STA 21+42.02

SHEET
M-2
SHEET 10 OF X