

SITE DESIGN INFORMATION, AND SERVICES NOT SUPPLIED BY ROMTEC UTILITIES


- GRADING
- WIRING & CONDUIT
- FENCING & PAVING
- SITE LIGHTING
- SITE UTILITIES (WATER, POWER, ETC)

FIR  
SAMPLE SITE LAYOUT  
9-28-17  
BASED ON SITE PLAN  
DWG RECEIVED 9-25-17

WET WELL DEPTH = 11'  
PUMP CABLE LENGTH = 32ft  
LEVEL SENSING CABLE LENGTH = 65ft

FE

NOT FOR CONSTRUCTION

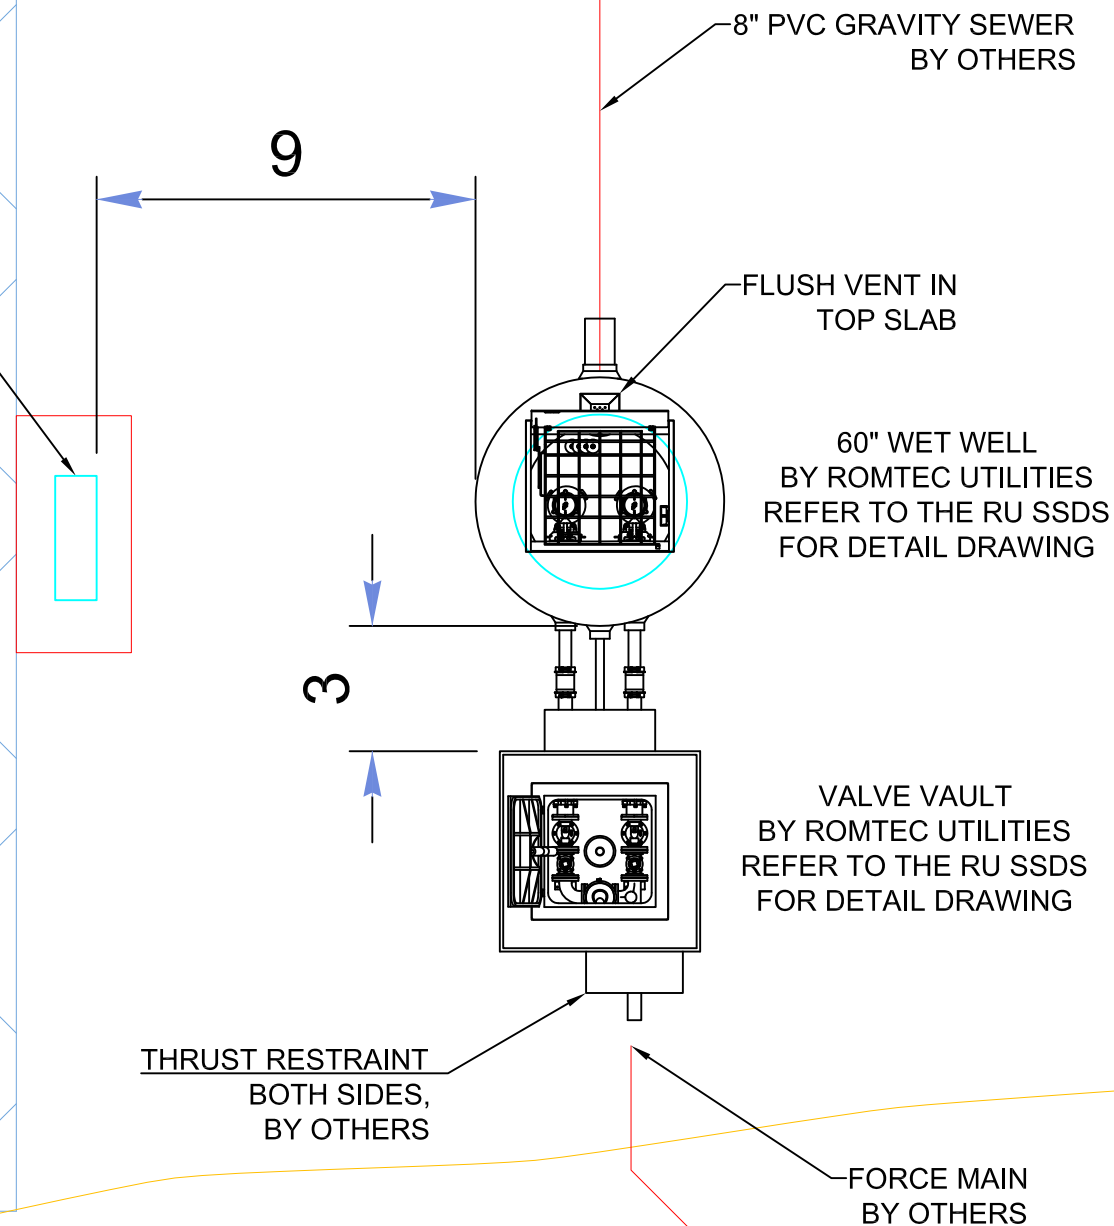

VERIFY SCALE  
BAR IS ONE INCH ON  
ORIGINAL DRAWING  
0 1"  
IF NOT ONE INCH ON  
ORIGINAL DRAWING  
SCALE ACCORDINGLY

DSN - AD  
DRN - AD  
CKD - AD  
DATE - 8-10-17

SAMPLE  
DRAWING

**ROMTEC  
UTILITIES**  
18240 NORTH BANK ROAD  
ROSEBURG, OREGON 97470  
(541) 496-9678  
FAX (541) 496-0804

FIR - ELM ELEMENTARY  
PROPOSED SITE PLAN LAYOUT

SHEET  
1 OF 1

JOB NUMBER  
RMTC  
0000

REVISION HISTORY  
REV 1 DATE APPROV


SITE DESIGN INFORMATION, AND SERVICES NOT SUPPLIED BY ROMTEC UTILITIES

- GRADING
- WIRING & CONDUIT
- FENCING & PAVING
- SITE LIGHTING
- SITE UTILITIES (WATER, POWER, ETC)

MONTROSE  
SAMPLE SITE LAYOUT  
9-28-17  
BASED ON SITE PLAN  
DWG RECEIVED 9-25-17

WET WELL DEPTH = 13'  
PUMP CABLE LENGTH = 50ft  
LEVEL SENSING CABLE LENGTH= 65ft

NOT FOR CONSTRUCTION

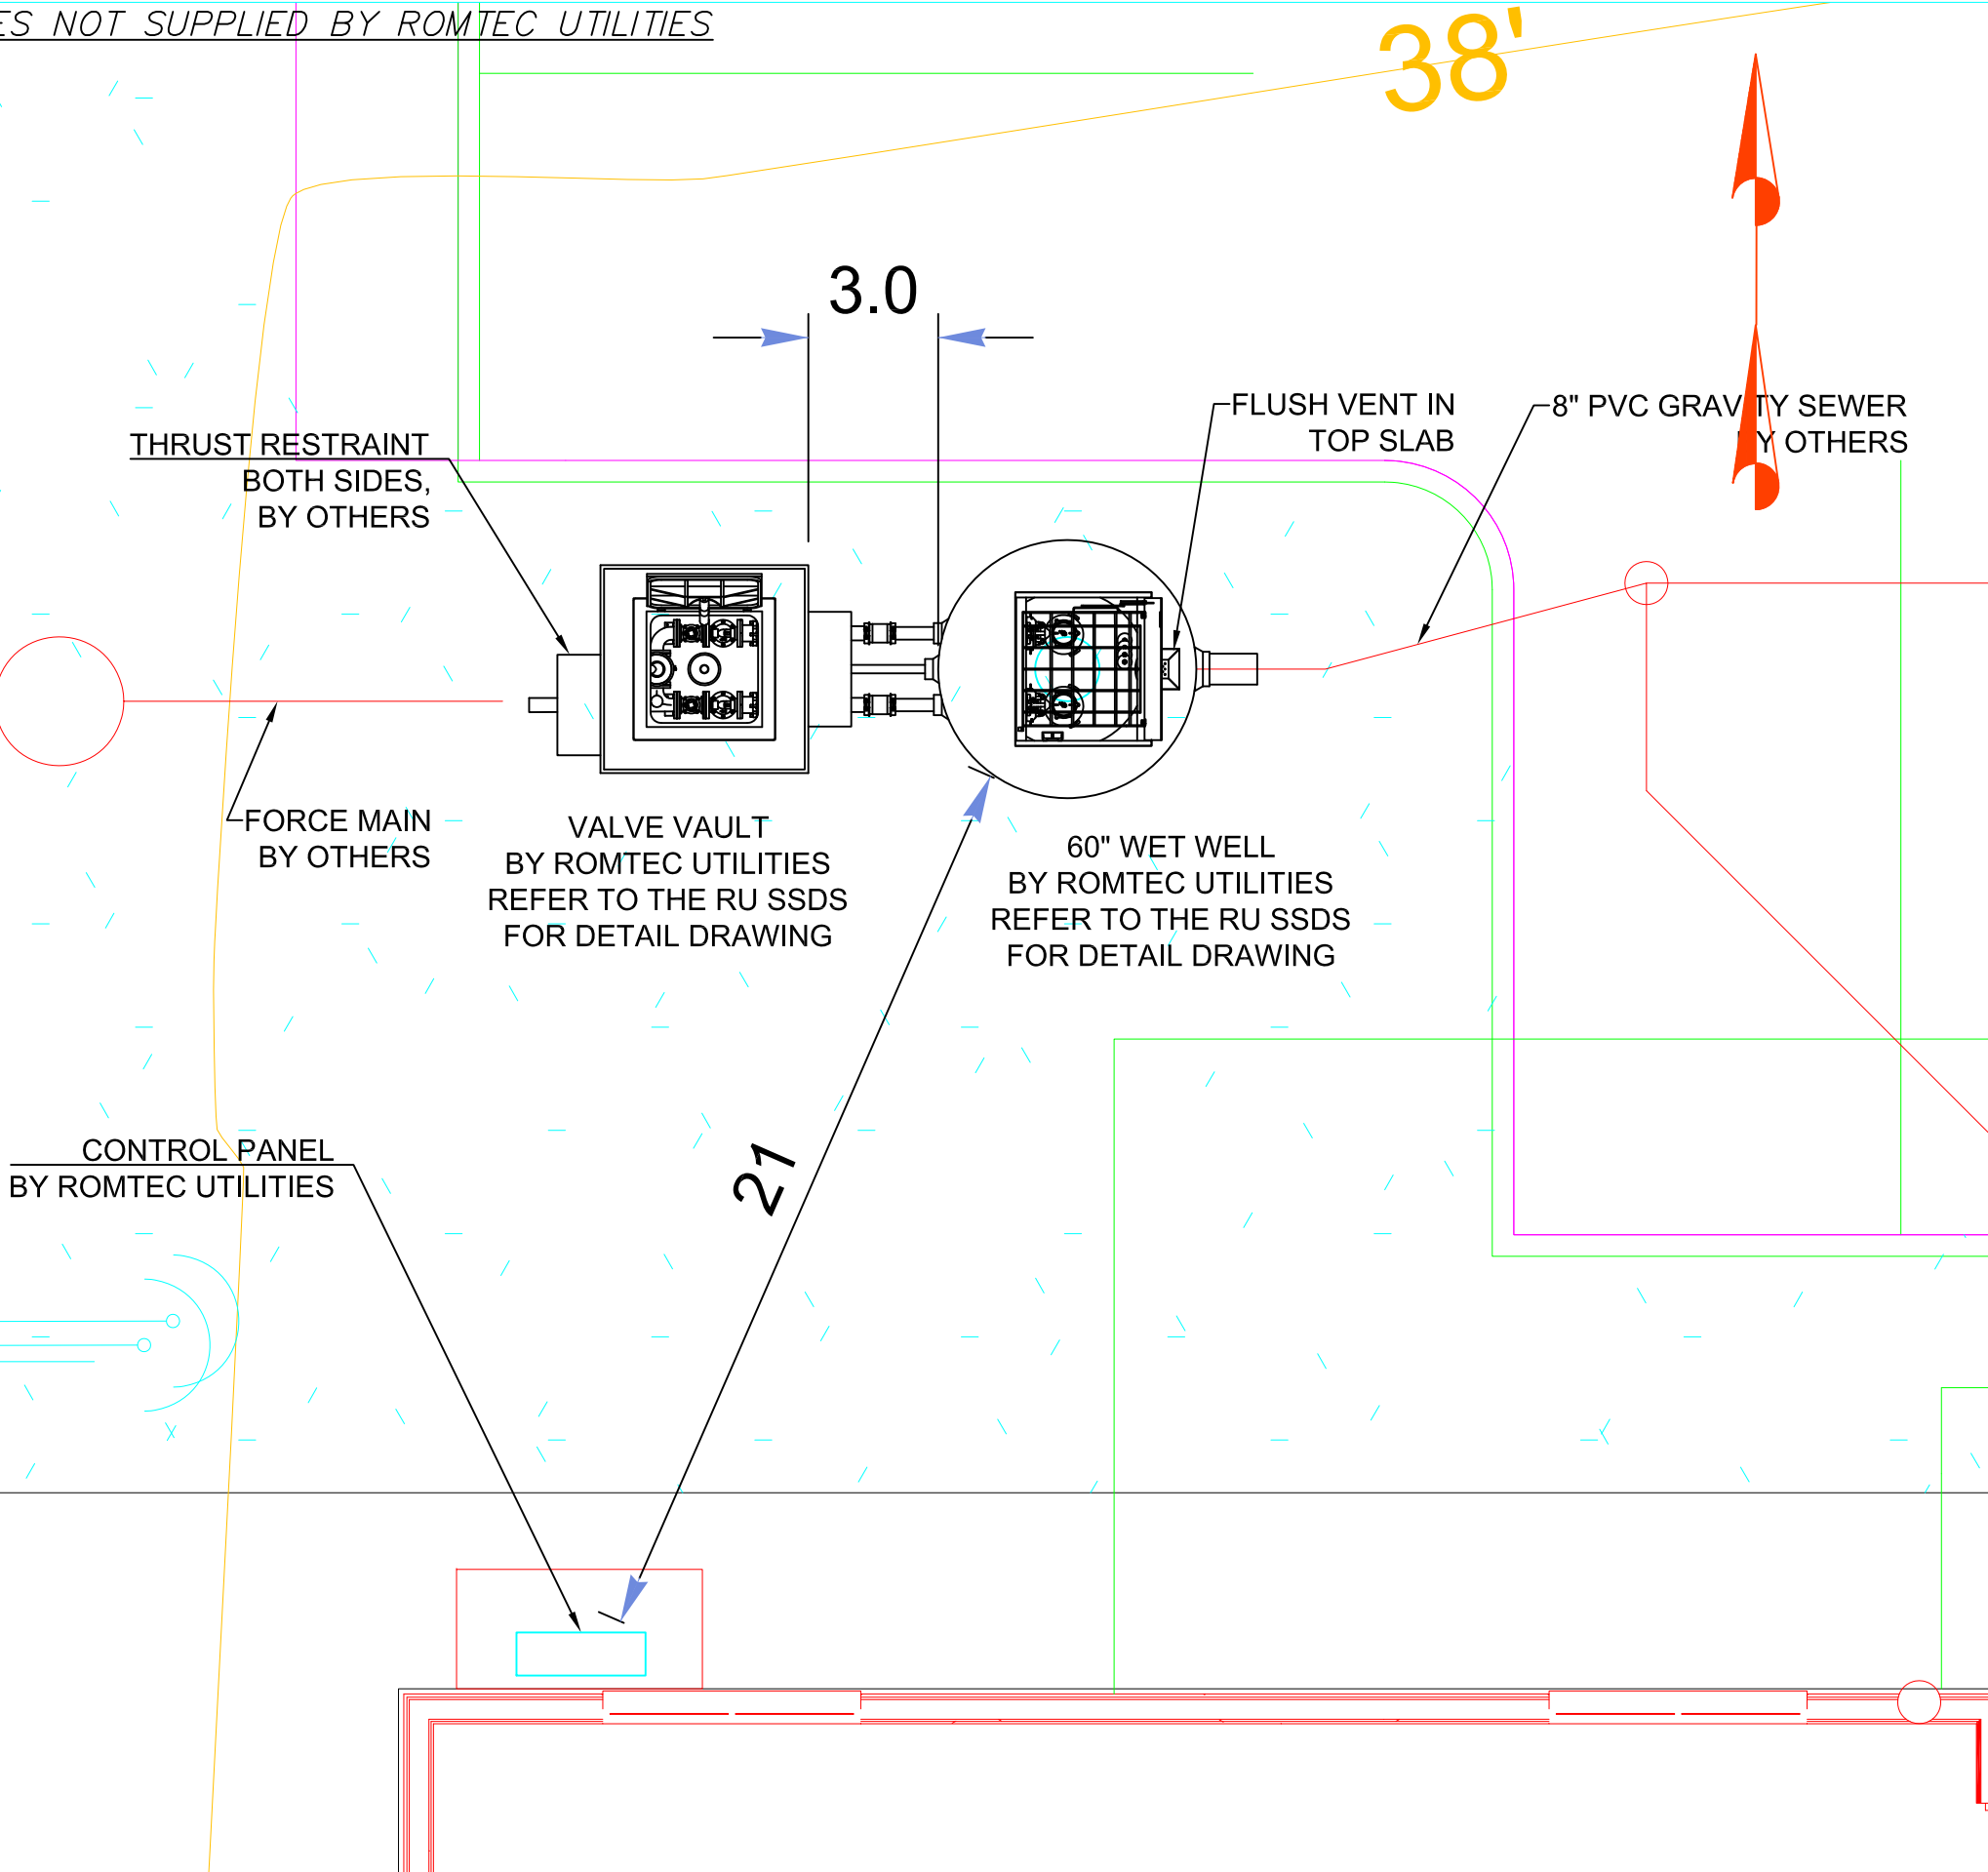

1	REV	DESCRIPTION	DATE	APPROV
REVISION HISTORY				

VERIFICATION SCALE  
1" = 10'-0"  
IF NOT ONE INCH ON THIS SHEET, ADJUST SCALES ACCORDINGLY

DSN - AD  
DRN - AD  
CKO - AD  
DATE - 8-10-17

**ROMTEC UTILITIES**  
18240 NORTH BANK ROAD  
ROSEBURG, OREGON 97470  
(541) 496-9678  
FAX (541) 496-0804

MONTROSE - ELM ELEMENTARY  
PROPOSED SITE PLAN LAYOUT

SHEET  
1 OF 1

JOB NUMBER  
RMTC  
0000