



ME: 03.2008-1007.dwg
 T:\California\6500\6388-BEAR-RIVER-BAND-00.dwg, 6388 ON WWP SITE PLAN.dwg

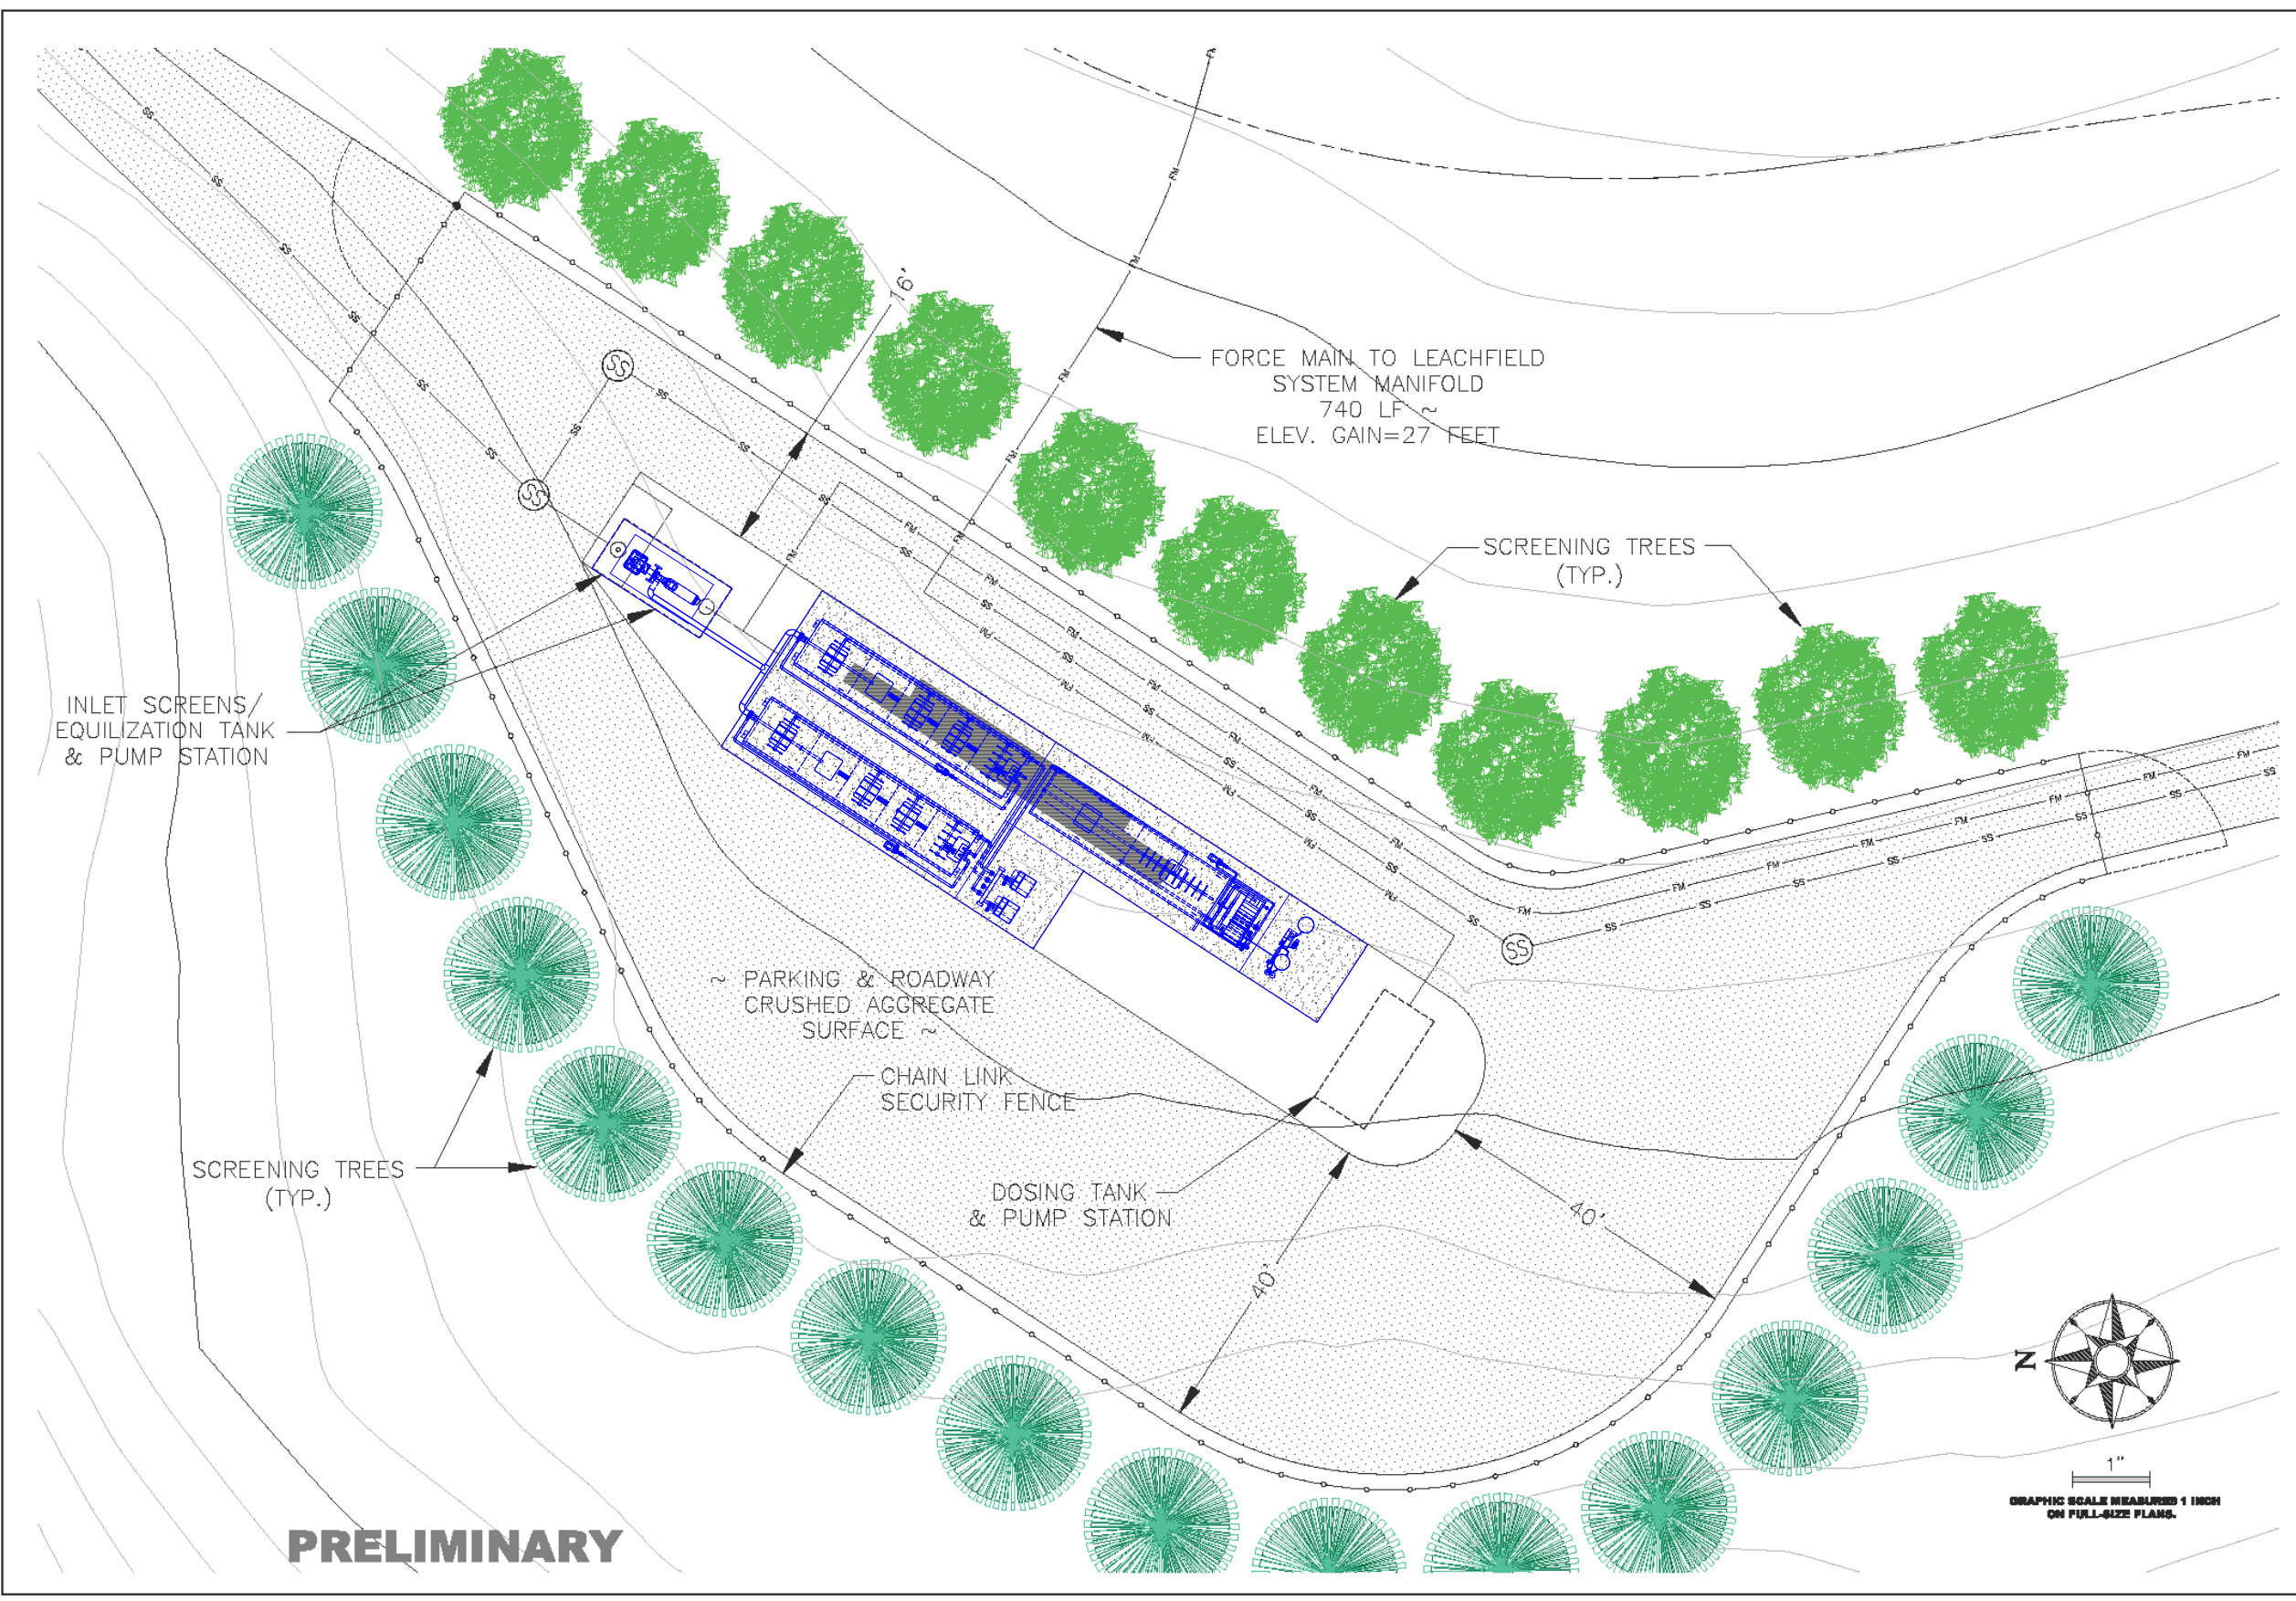

PRELIMINARY

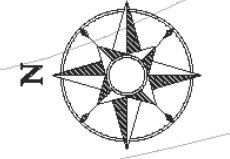

1" = 10'
 GRAPHIC SCALE MEASURED 1 INCH ON FULL-SIZE PLANS.

DRAFT

LACO ASSOCIATES
 CONSULTING ENGINEERS
 21 W 4TH ST. EUREKA, CA 95501 (707)443-5054

NO.	REVISION	BY	CHK	DATE

TISH NON VILLAGE
WASTEWATER TREATMENT PROJECT
TREATMENT PLANT SITE PLAN
BEAR RIVER BAND OF
ROHNERVILLE RANCHERIA
HUMBOLDT COUNTY, CALIFORNIA

SCALE 1" = 10'
 DRAWN DAN
 CHECK LMO
 APPVD LMO
 DATE 03/04/09
 JOB NO. 6388.00
 SHEET **1B**