

2.01 SITE LAYOUT

PRELIMINARY SITE LAYOUT

BASED ON SITE PLANS RECEIVED 8-29-19

WET WELL DEPTH: 13.2'

DISTANCE TO TERMINATION: 25' MAX

NOTE: CABLES TO BE TERMINATED IN APPROVED JUNCTION BOX OR CONTROL PANEL.

APPROX. CABLE LENGTH NEEDED: 50' @ MAX

PUMP CABLE LENGTH: 50'

TRANSDUCER CABLE LENGTH: N/A

FLOAT CABLE LENGTH: 65'


NOTE: SITE MATERIALS, DESIGN INFORMATION, AND SERVICES **NOT** SUPPLIED BY ROMTEC UTILITIES:

- GRADING
- WIRING AND CONDUIT
- FENCING AND PAVING
- SITE LIGHTING
- SITE UTILITIES (WATER, POWER, ETC)
- SCADA ANTENNA
- ALL ON-SITE INSTALLATION

2.5

3.0

N82°48'42"W 80.44'

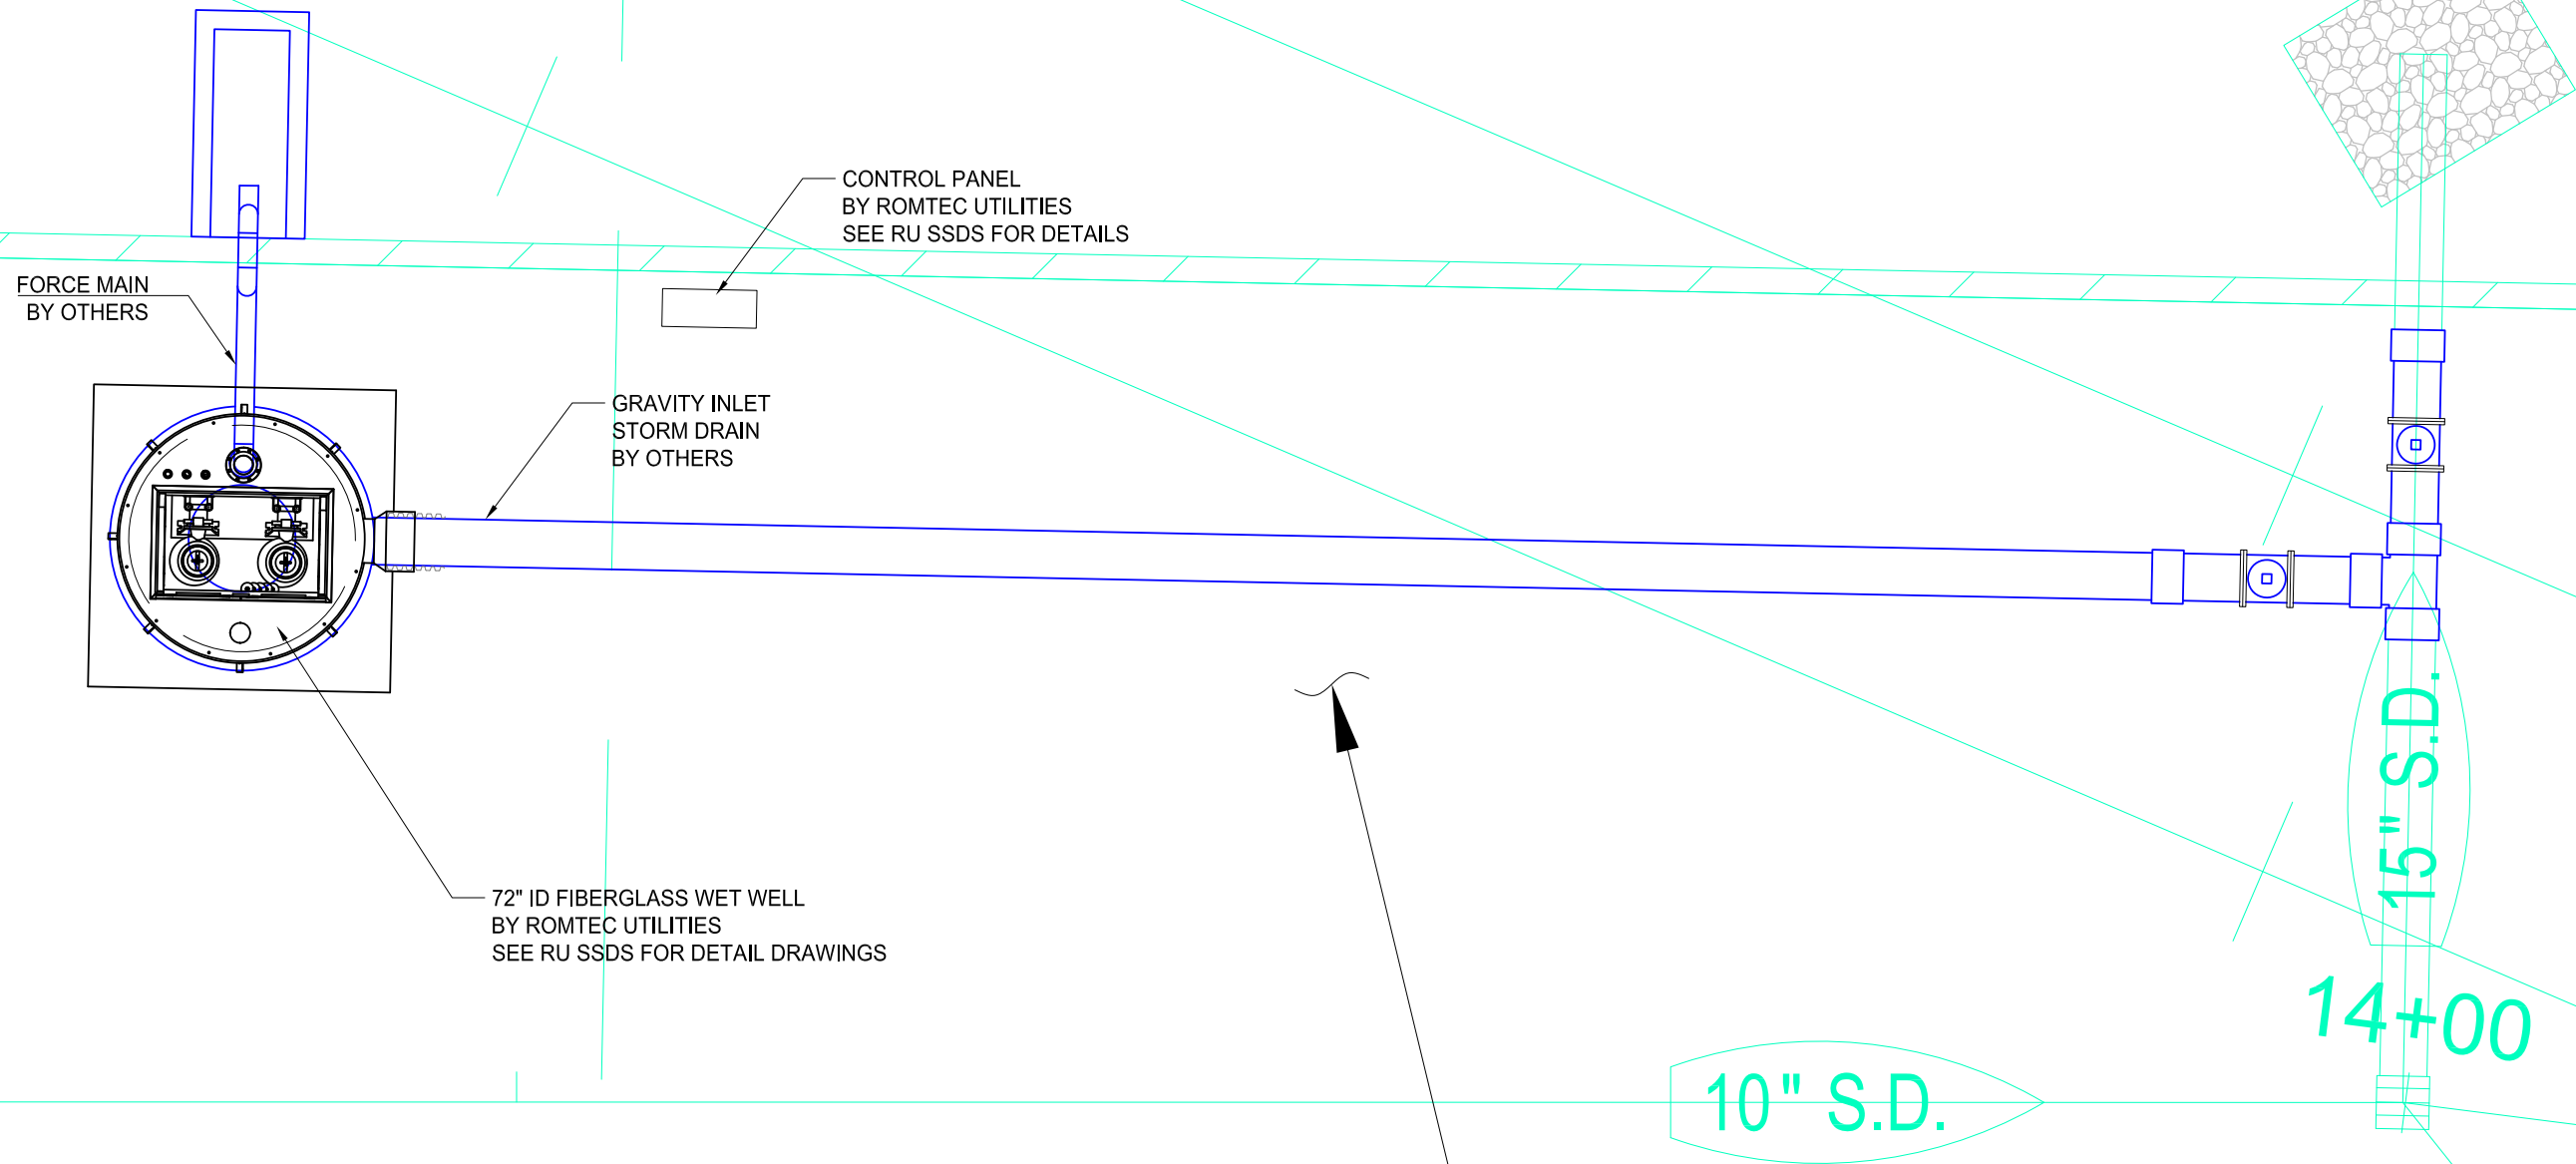

CONTROL PANEL
BY ROMTEC UTILITIES
SEE RU SSDS FOR DETAILS

FORCE MAIN
BY OTHERS

GRAVITY INLET
STORM DRAIN
BY OTHERS

72" ID FIBERGLASS WET WELL
BY ROMTEC UTILITIES
SEE RU SSDS FOR DETAIL DRAWINGS

15" S.D.

10" S.D.

14+00

<p>ROMTEC UTILITIES 18240 NORTH BANK ROAD ROSEBURG, OREGON 97470 PHONE: (541) 496-9678 WWW.ROMTECUTILITIES.COM</p>	<p>DATE: 9-5-19</p>							
	<p>REVISION HISTORY</p> <table border="1"> <thead> <tr> <th>REV</th> <th>DATE</th> <th>DESCRIPTION</th> <th>BY</th> </tr> </thead> <tbody> <tr> <td>0</td> <td>9/5/2019</td> <td>ADDITIONAL DETAILING FOR DESIGN SUBMISSION</td> <td>KB</td> </tr> </tbody> </table>	REV	DATE	DESCRIPTION	BY	0	9/5/2019	ADDITIONAL DETAILING FOR DESIGN SUBMISSION
REV	DATE	DESCRIPTION	BY					
0	9/5/2019	ADDITIONAL DETAILING FOR DESIGN SUBMISSION	KB					
<p>TRANS BAY CABLE CONVERTER PITTSBURG, CA</p>	<p>STORMWATER PUMP STATIONS LAYOUT DRAWING NORTH PUMP STATION</p>							
<p>MECHANICAL SHEET 2 OF 5</p>	<p>VERIFY SCALE CONSTRUCTION SCALE 1" = 10'-0"</p>							

© 2019 ROMTEC INC. ALL RIGHTS RESERVED. THESE PLANS AND DRAWINGS MAY NOT BE REPRODUCED, ADAPTED, OR FURTHER DISTRIBUTED, AND NO COMPONENTS MAY BE CONSTRUCTED FROM THESE PLANS, WITHOUT WRITTEN PERMISSION OF ROMTEC, INC.

2.01 SITE LAYOUT

PRELIMINARY SITE LAYOUT

BASED ON SITE PLANS RECEIVED 8-29-19

WET WELL DEPTH: 11.2'

DISTANCE TO TERMINATION: 27' MAX

NOTE: CABLES TO BE TERMINATED IN APPROVED JUNCTION BOX OR CONTROL PANEL.

APPROX. CABLE LENGTH NEEDED: 50' @ MAX

PUMP CABLE LENGTH: 50'


TRANSDUCER CABLE LENGTH: N/A

FLOAT CABLE LENGTH: 65'

NOTE: SITE MATERIALS, DESIGN INFORMATION, AND SERVICES **NOT** SUPPLIED BY ROMTEC UTILITIES:

- GRADING
- WIRING AND CONDUIT
- FENCING AND PAVING
- SITE LIGHTING
- SITE UTILITIES (WATER, POWER, ETC.)
- SCADA ANTENNA
- ALL ON-SITE INSTALLATION

**INSTALL
ON EXIS
SANITARI
SEE GAT**

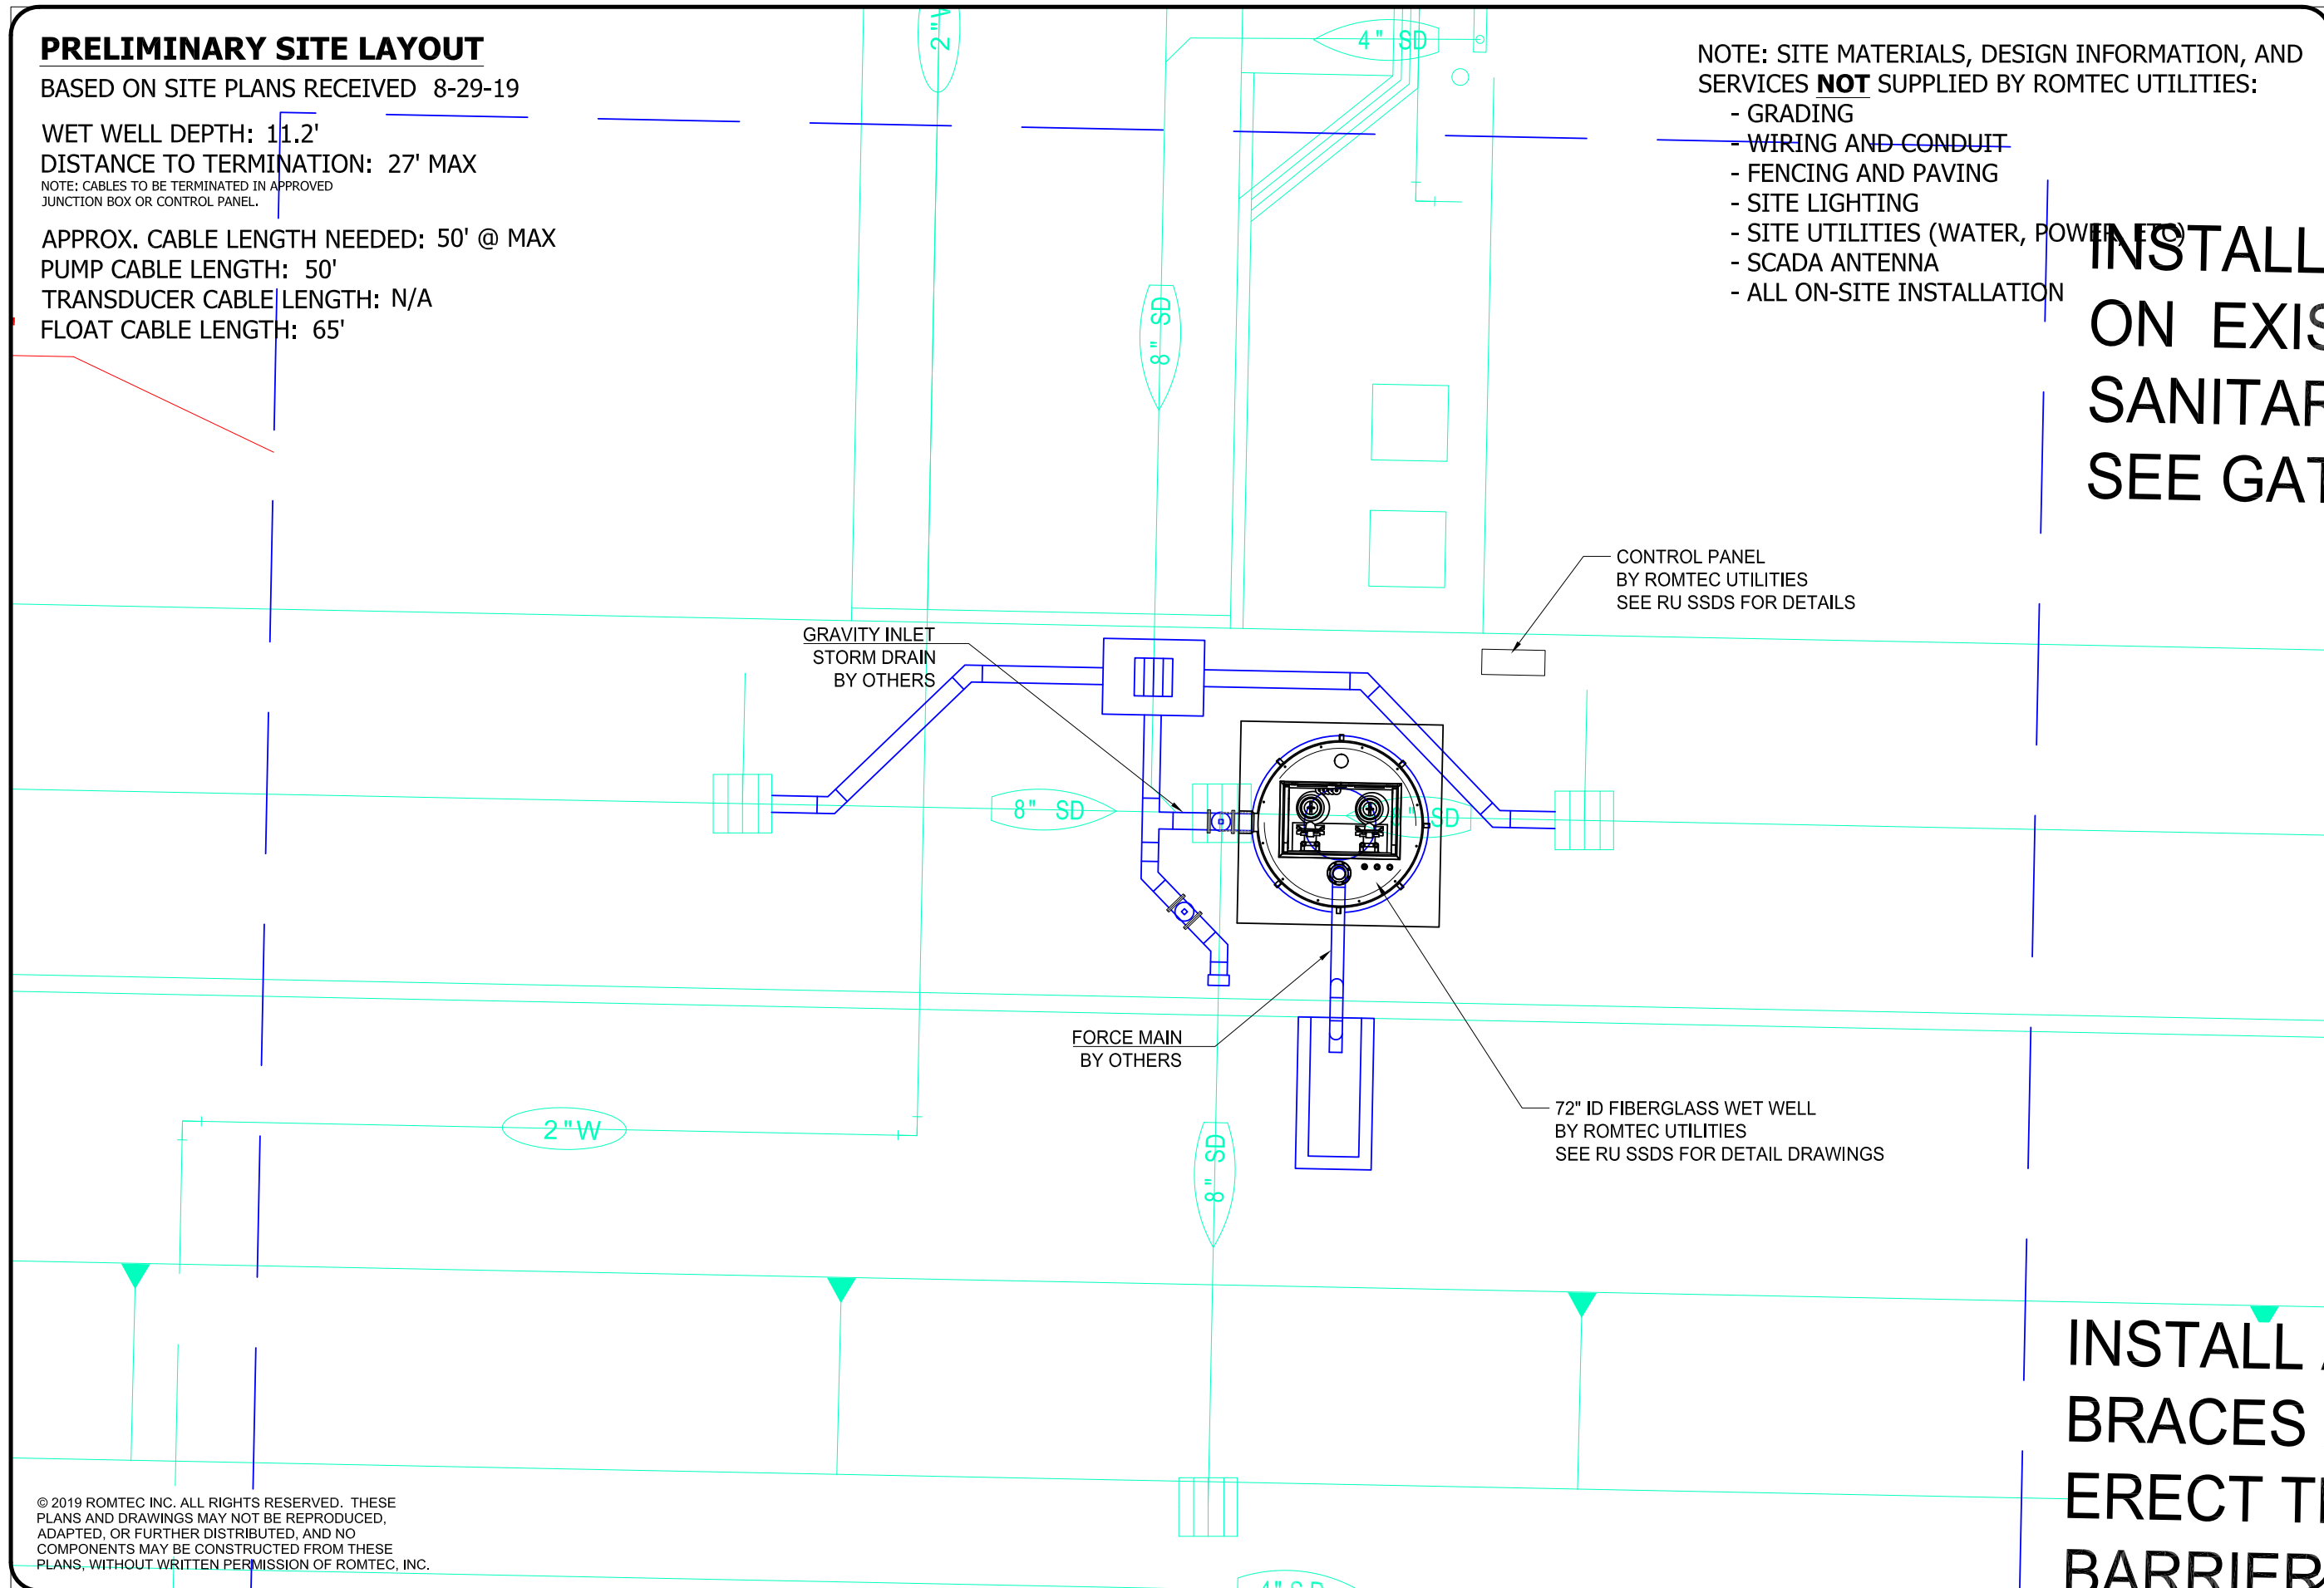

CONTROL PANEL
BY ROMTEC UTILITIES
SEE RU SSDS FOR DETAILS

GRAVITY INLET
STORM DRAIN
BY OTHERS

FORCE MAIN
BY OTHERS

72" ID FIBERGLASS WET WELL
BY ROMTEC UTILITIES
SEE RU SSDS FOR DETAIL DRAWINGS

**INSTALL
BRACES
ERECT T
BARRIER**

VERIFY SCALE
DRAWING HAS BEEN
CHECKED FOR
CONFORMANCE WITH
THE LATEST CODE BOOK

0 1"

DATE: 9-5-19

DSN: DRN: KB CKD:

ROMTEC UTILITIES

18240 NORTH BANK ROAD
ROSEBURG, OREGON 97470
PHONE: (541) 496-9678
WWW.ROMTECUTILITIES.COM

TRANS BAY CABLE CONVERTER
PITTSBURG, CA

STORMWATER PUMP STATIONS
LAYOUT DRAWING
SOUTH PUMP STATION

© 2019 ROMTEC INC. ALL RIGHTS RESERVED. THESE PLANS AND DRAWINGS MAY NOT BE REPRODUCED, ADAPTED, OR FURTHER DISTRIBUTED, AND NO COMPONENTS MAY BE CONSTRUCTED FROM THESE PLANS, WITHOUT WRITTEN PERMISSION OF ROMTEC, INC.