

4" HDPE SDR11 DIPS
FORCE MAIN
BY OTHERS

VALVE VAULT
BY ROMTEC UTILITIES
REFER TO RU SSDS FOR
DETAILS DRAWINGS

72" WET WELL
BY ROMTEC UTILITIES
REFER TO RU SSDS FOR
DETAILS DRAWINGS

GRAVITY INLET PIPE
8" PVC, BY OTHERS



WET WELL FLUSH VENT
BY ROMTEC UTILITIES

THRUST BLOCKS
BOTH SIDES OF VAULT
BY OTHERS

CONTROL PANEL
BY ROMTEC UTILITIES
REFER TO RU SSDS FOR
DETAILS DRAWINGS

LUSTED PUMP STATION
SAMPLE SITE LAYOUT
6-21-19
BASED ON SITE PLAN
DWG RECEIVED 3-20-19
NOT FOR CONSTRUCTION

1	REVISED PER COMMENTS - BIGGER VALVE VAULT	6-21-19	AD
REV	DESCRIPTION	DATE	APPROV
REVISION HISTORY			

VERIFY SCALE
BASE IS ONE INCH ON
ORIGINAL DRAWING
1" = 10'
IF NOT ONE INCH ON
SCALE, ACCORDINGLY

DSN -
DRN - AM
CKD -
DATE - 3-21-19

**SAMPLE
DRAWING**

**ROMTEC
UTILITIES**
18240 NORTH BANK ROAD
ROSEBURG, OREGON 97470
(541) 496-9678
FAX (541) 496-0804

**LUSTED PUMP STATION
SITE PLAN LAYOUT**


SHEET
2 OF 5

JOB NUMBER
**RMTC
0000**

SITE MATERIALS, DESIGN INFORMATION, AND SERVICES NOT SUPPLIED BY ROMTEC UTILITIES

- GRADING
- WIRING & CONDUIT
- FENCING & PAVING
- SITE LIGHTING
- SITE UTILITIES (WATER, POWER, ETC)
- SCADA ANTENNA
- ALL ON-SITE INSTALLATION

GP GI

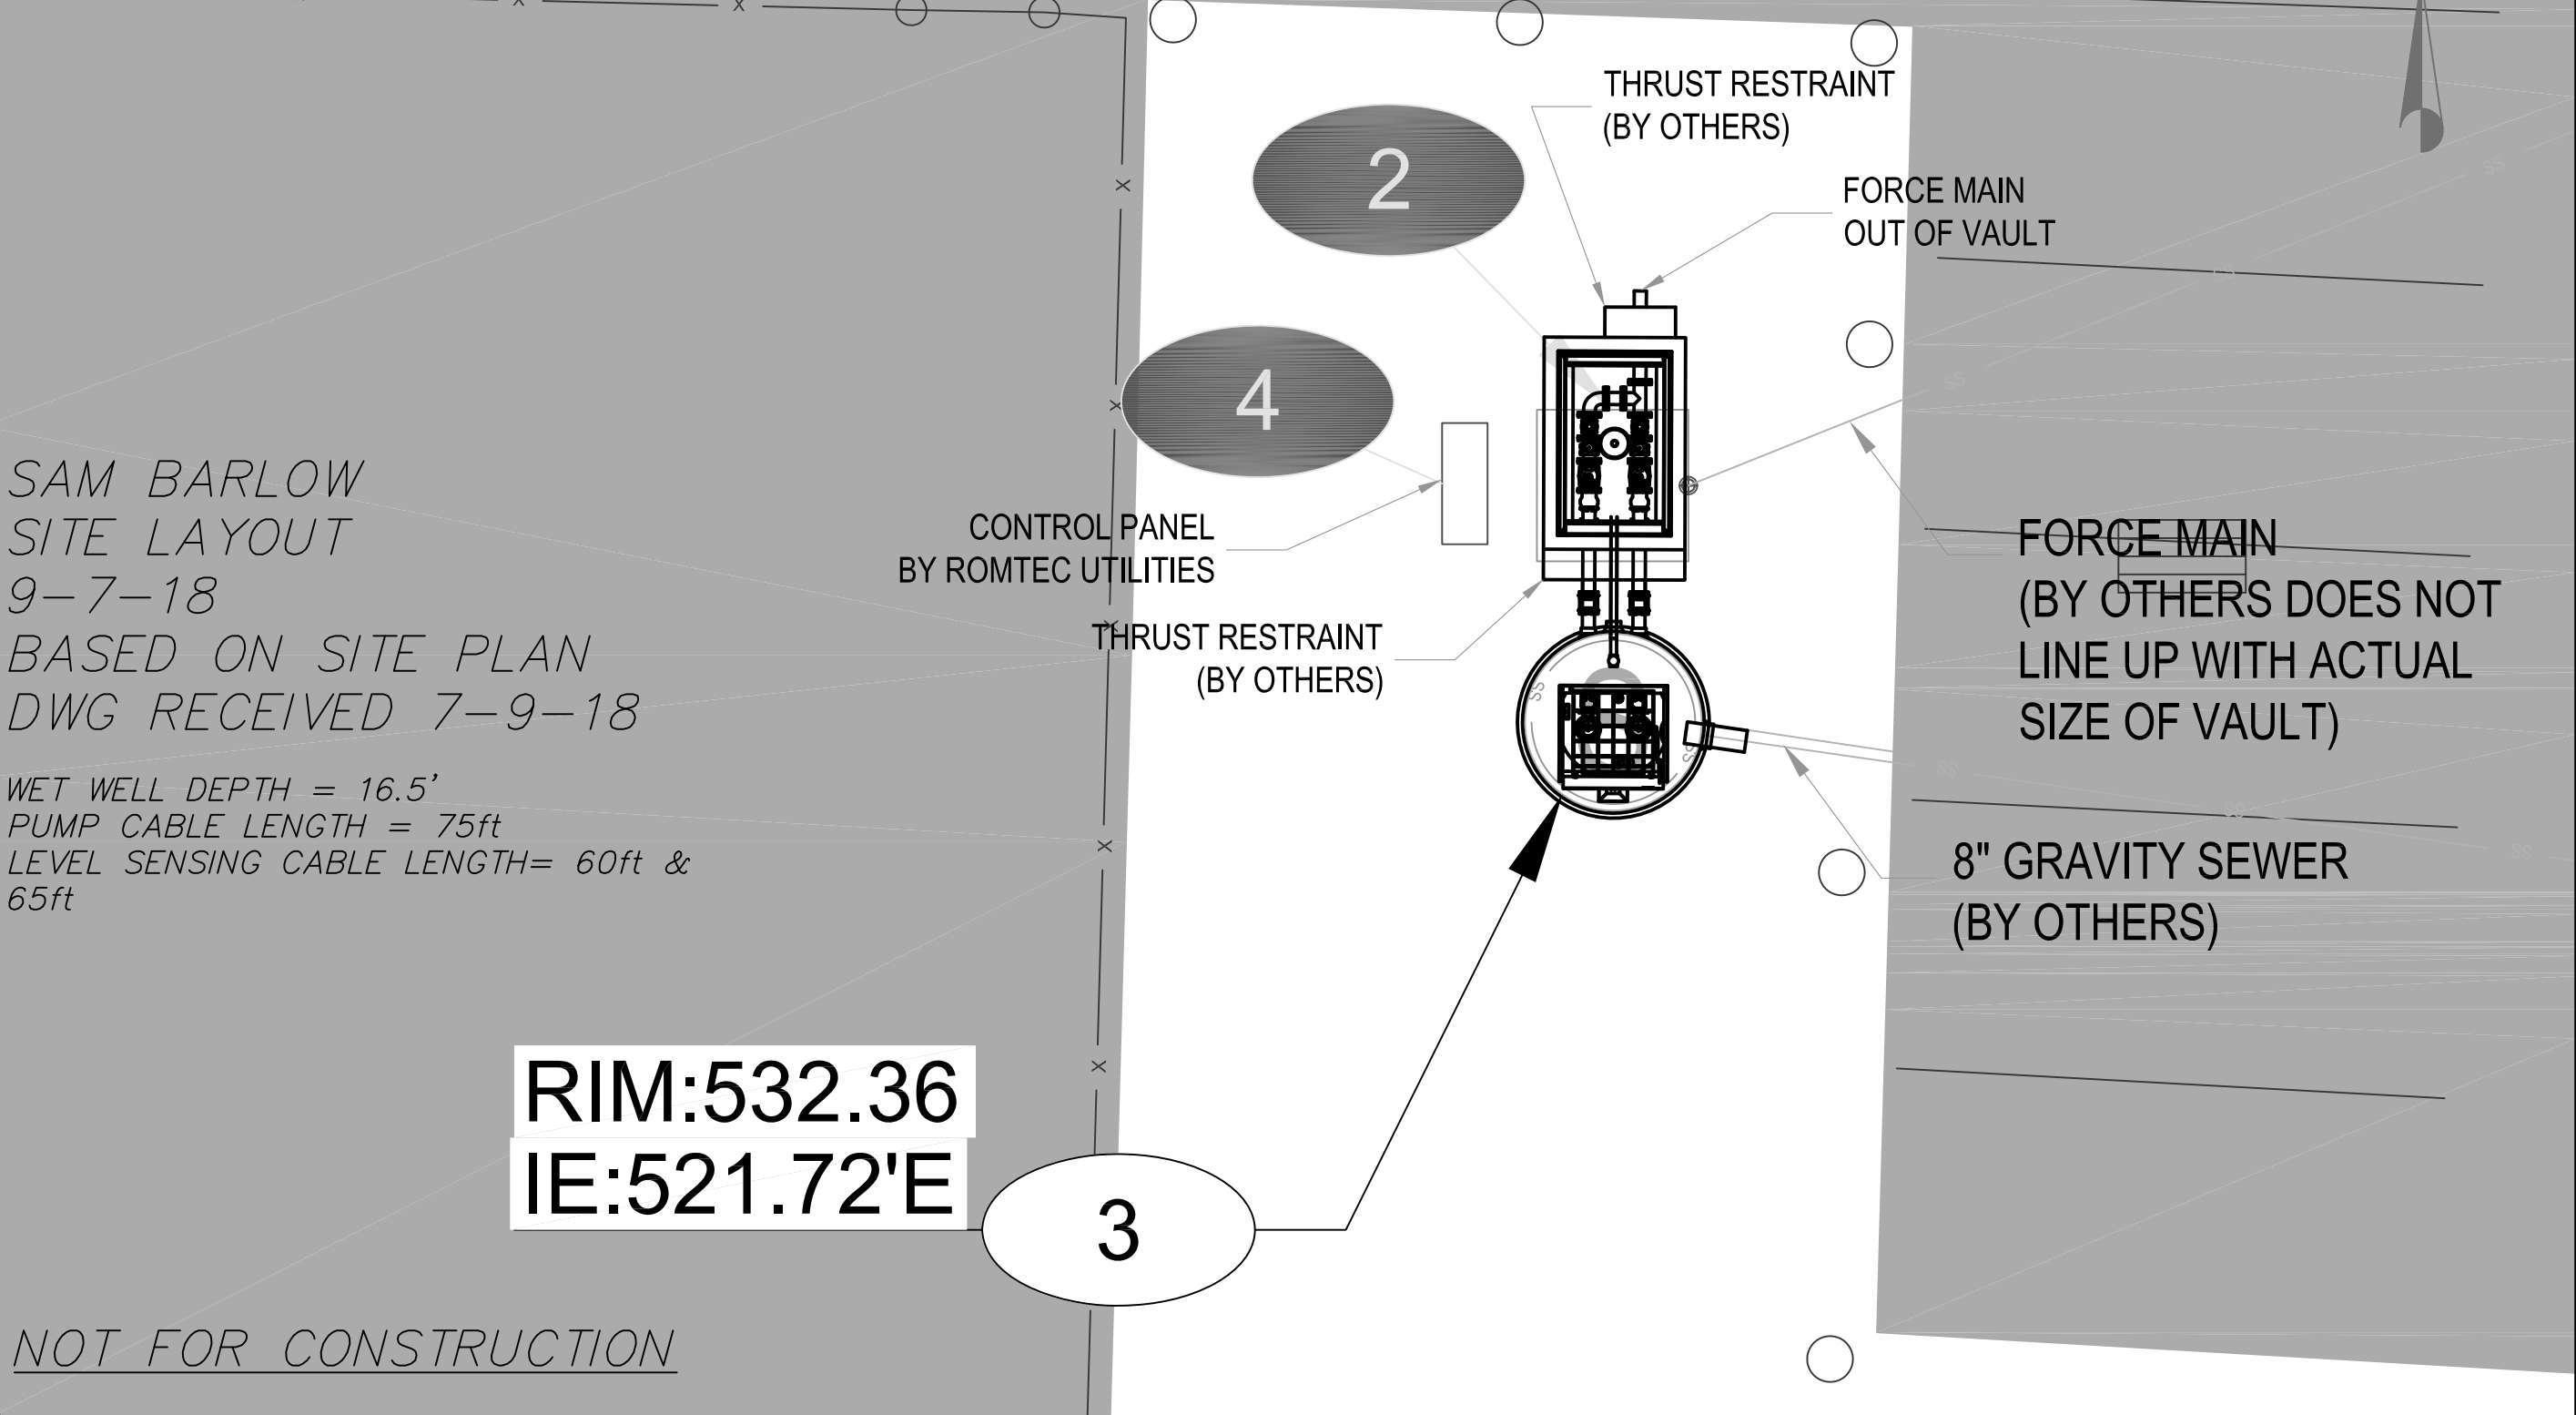


SAM BARLOW
 SITE LAYOUT
 9-7-18
 BASED ON SITE PLAN
 DWG RECEIVED 7-9-18

WET WELL DEPTH = 16.5'
 PUMP CABLE LENGTH = 75ft
 LEVEL SENSING CABLE LENGTH = 60ft &
 65ft

RIM:532.36
IE:521.72'E

 NOT FOR CONSTRUCTION



VERIFY SCALE
 BAR IS ONE INCH ON
 ORIGINAL DRAWING
 1"
 IF NOT ONE INCH ON
 SCALES ACCORDINGLY

DESIGN - AD
 DRAWN - AD
 CHECKED - AD
 DATE - 9-7-18

ROMTEC UTILITIES
 18240 NORTH BANK ROAD
 ROSEBURG, OREGON 97470
 (541) 496-9678
 FAX (541) 496-0804

SAM BARLOW
 SITE PLAN LAYOUT

SHEET
 1 OF 1

JOB NUMBER
 RMT
 0000

REV	DESCRIPTION	DATE	APPROV
1			